



FOR CONTINUATION REFER TO DRG. 70005333-068-02-GA-01 TOP VIEWPORT  
 FOR CONTINUATION REFER TO DRG. 70005333-068-02-GA-01 BOTTOM VIEWPORT

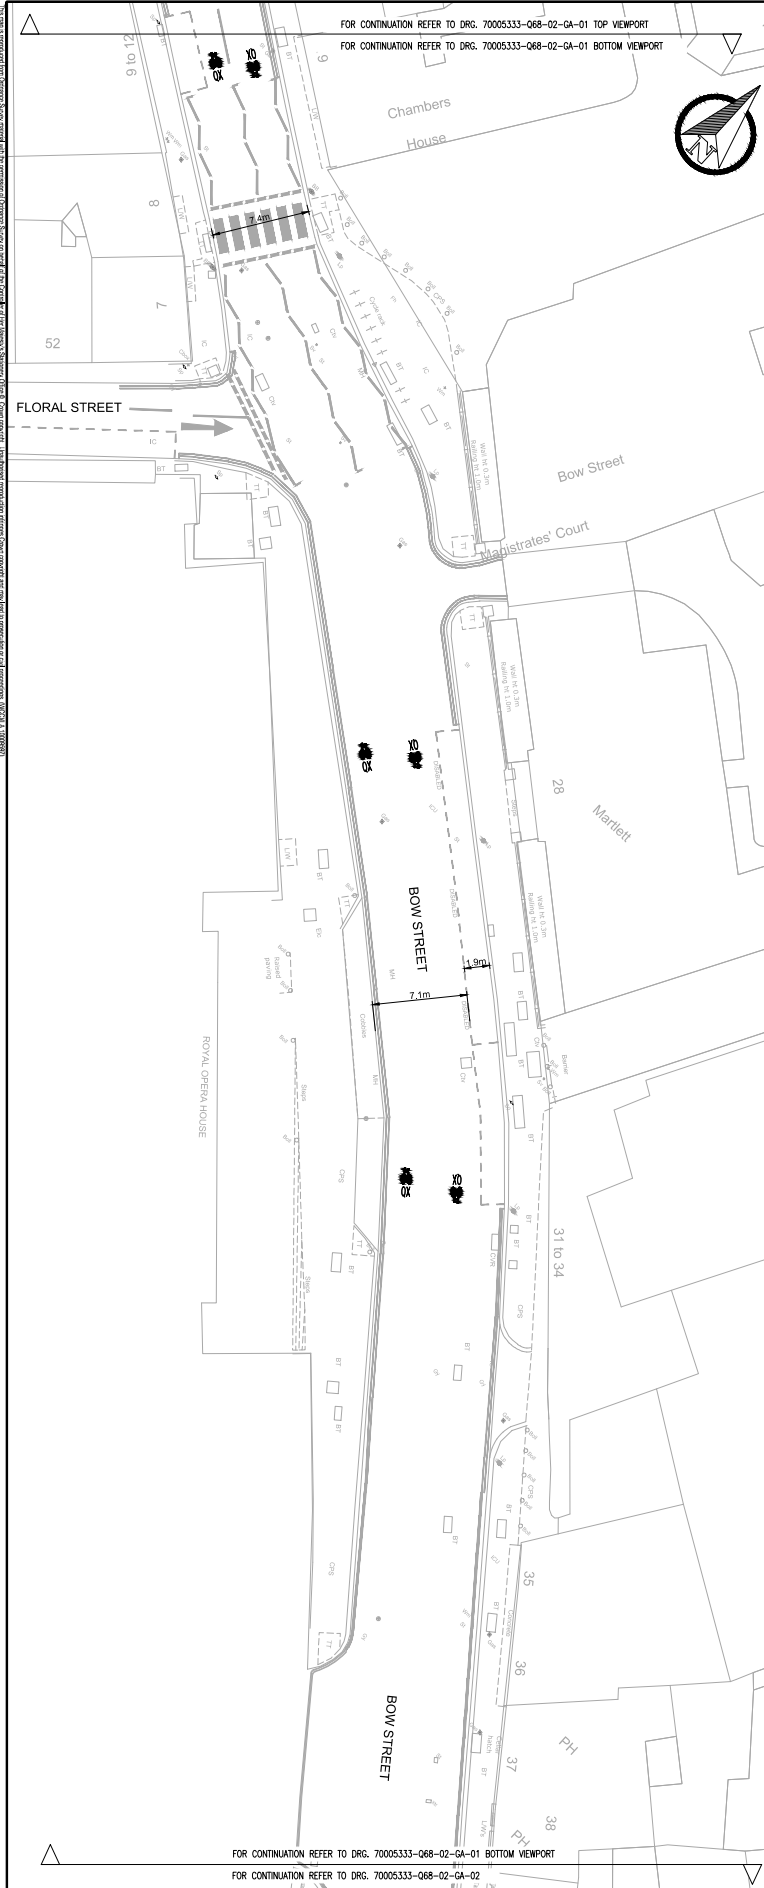

FOR CONTINUATION REFER TO DRG. 70005333-068-02-GA-01 TOP VIEWPORT  
 FOR CONTINUATION REFER TO DRG. 70005333-068-02-GA-02

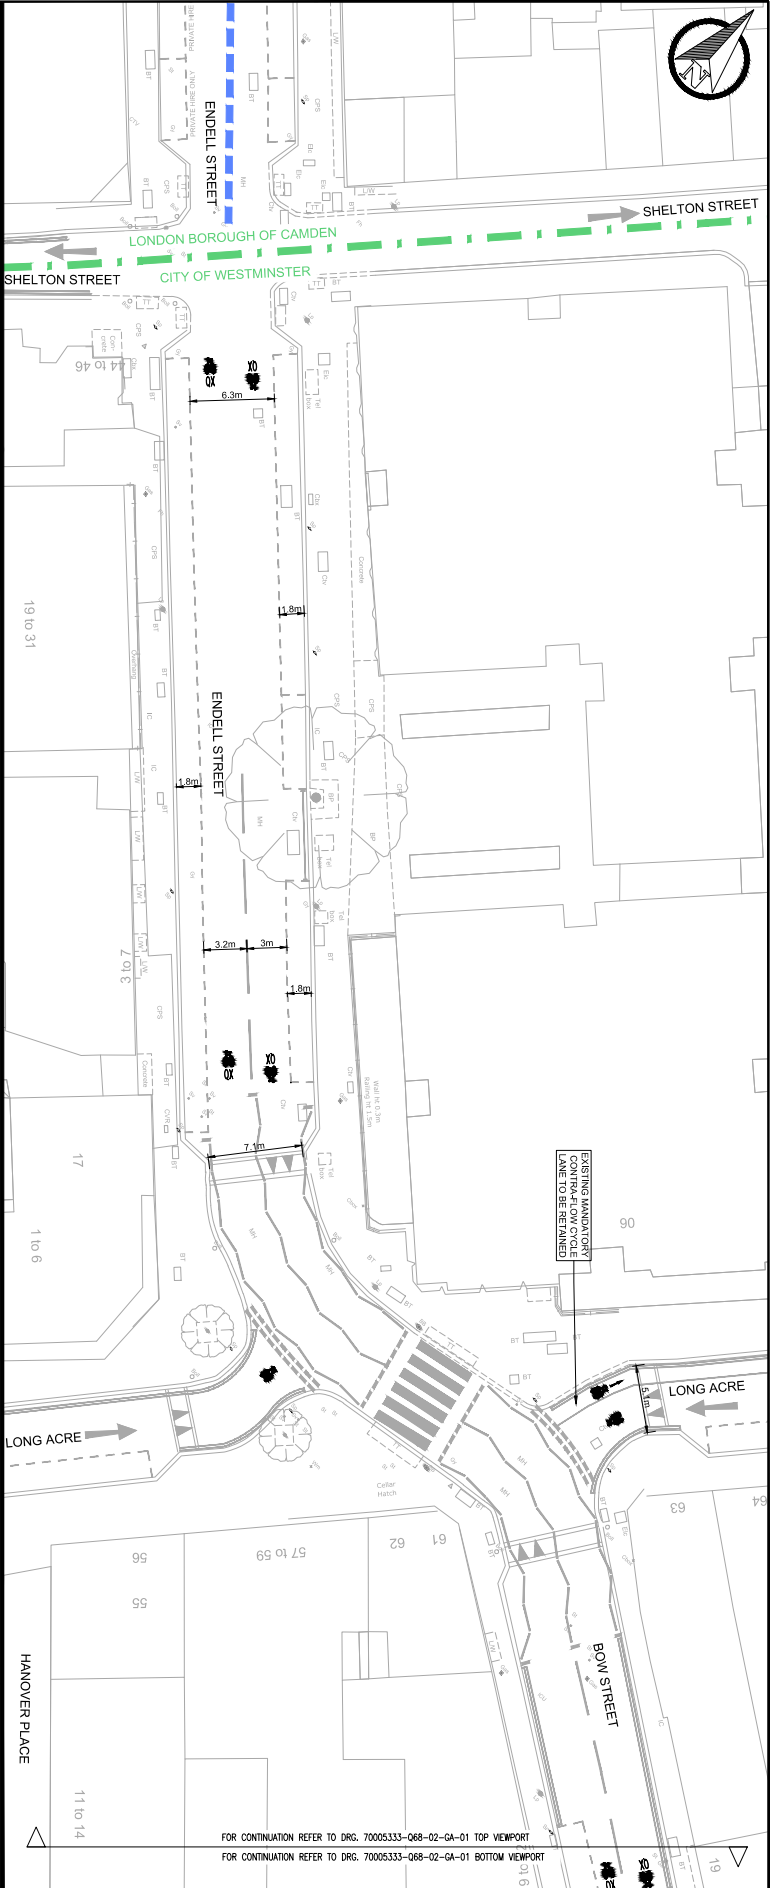

FOR CONTINUATION REFER TO DRG. 70005333-068-02-GA-01 TOP VIEWPORT  
 FOR CONTINUATION REFER TO DRG. 70005333-068-02-GA-01 BOTTOM VIEWPORT

**City of Westminster**

**WSP | PARSONS | BRINCKERHOFF**

25 Abchurch Lane, London, EC4A 3DF, UK  
 www.wspbrinck.com www.parsonsb.com

**GOINWAY**

**INITIAL DESIGN**

NO.	DATE	BY	CHKD	DESCRIPTION
1	14/02/16	CP	FR	ISSUED FOR PERMIT
2	15/02/16	CP	FR	ISSUED FOR PERMIT
3	15/02/16	CP	FR	ISSUED FOR PERMIT

**PROJECT**  
 CENTRAL LONDON CYCLE GRID  
 QUIETWAY ROUTE BLOOMSBURY TO SOUTH BANK

**TITLE**  
 ENDELL STREET TO WATERLOO BRIDGE  
 GENERAL ARRANGEMENT

**SHEET** 1 OF 4

DATE	03/02/2016	DESIGNER	CP
DATE	12/02	CHECKER	CH
DATE	15/02/16	APPROVED	AI
DATE	15/02/16	ISSUED	AI

PROJECT NO: 70005333  
 SHEET NO: 01/15878  
 REV: A

**KEY**


- EXISTING DIRECTION OF TRAVEL
- ADJOINING CYCLE ROUTE
- BOROUGH BOUNDARY

**NOTES**

- PROPOSED LIGHTING LAYOUT HAS NOT BEEN SHOWN ON THIS STAGE DRAWINGS
- REFER TO DRAWING NUMBER 70005333-068-02-GA-01 FOR ALL OTHER ITEMS RELATING TO THIS DRAWING

**EXISTING MANHOLES ARE TO BE RETAINED**

Quietway to  
Bloomsbury to  
Southbank

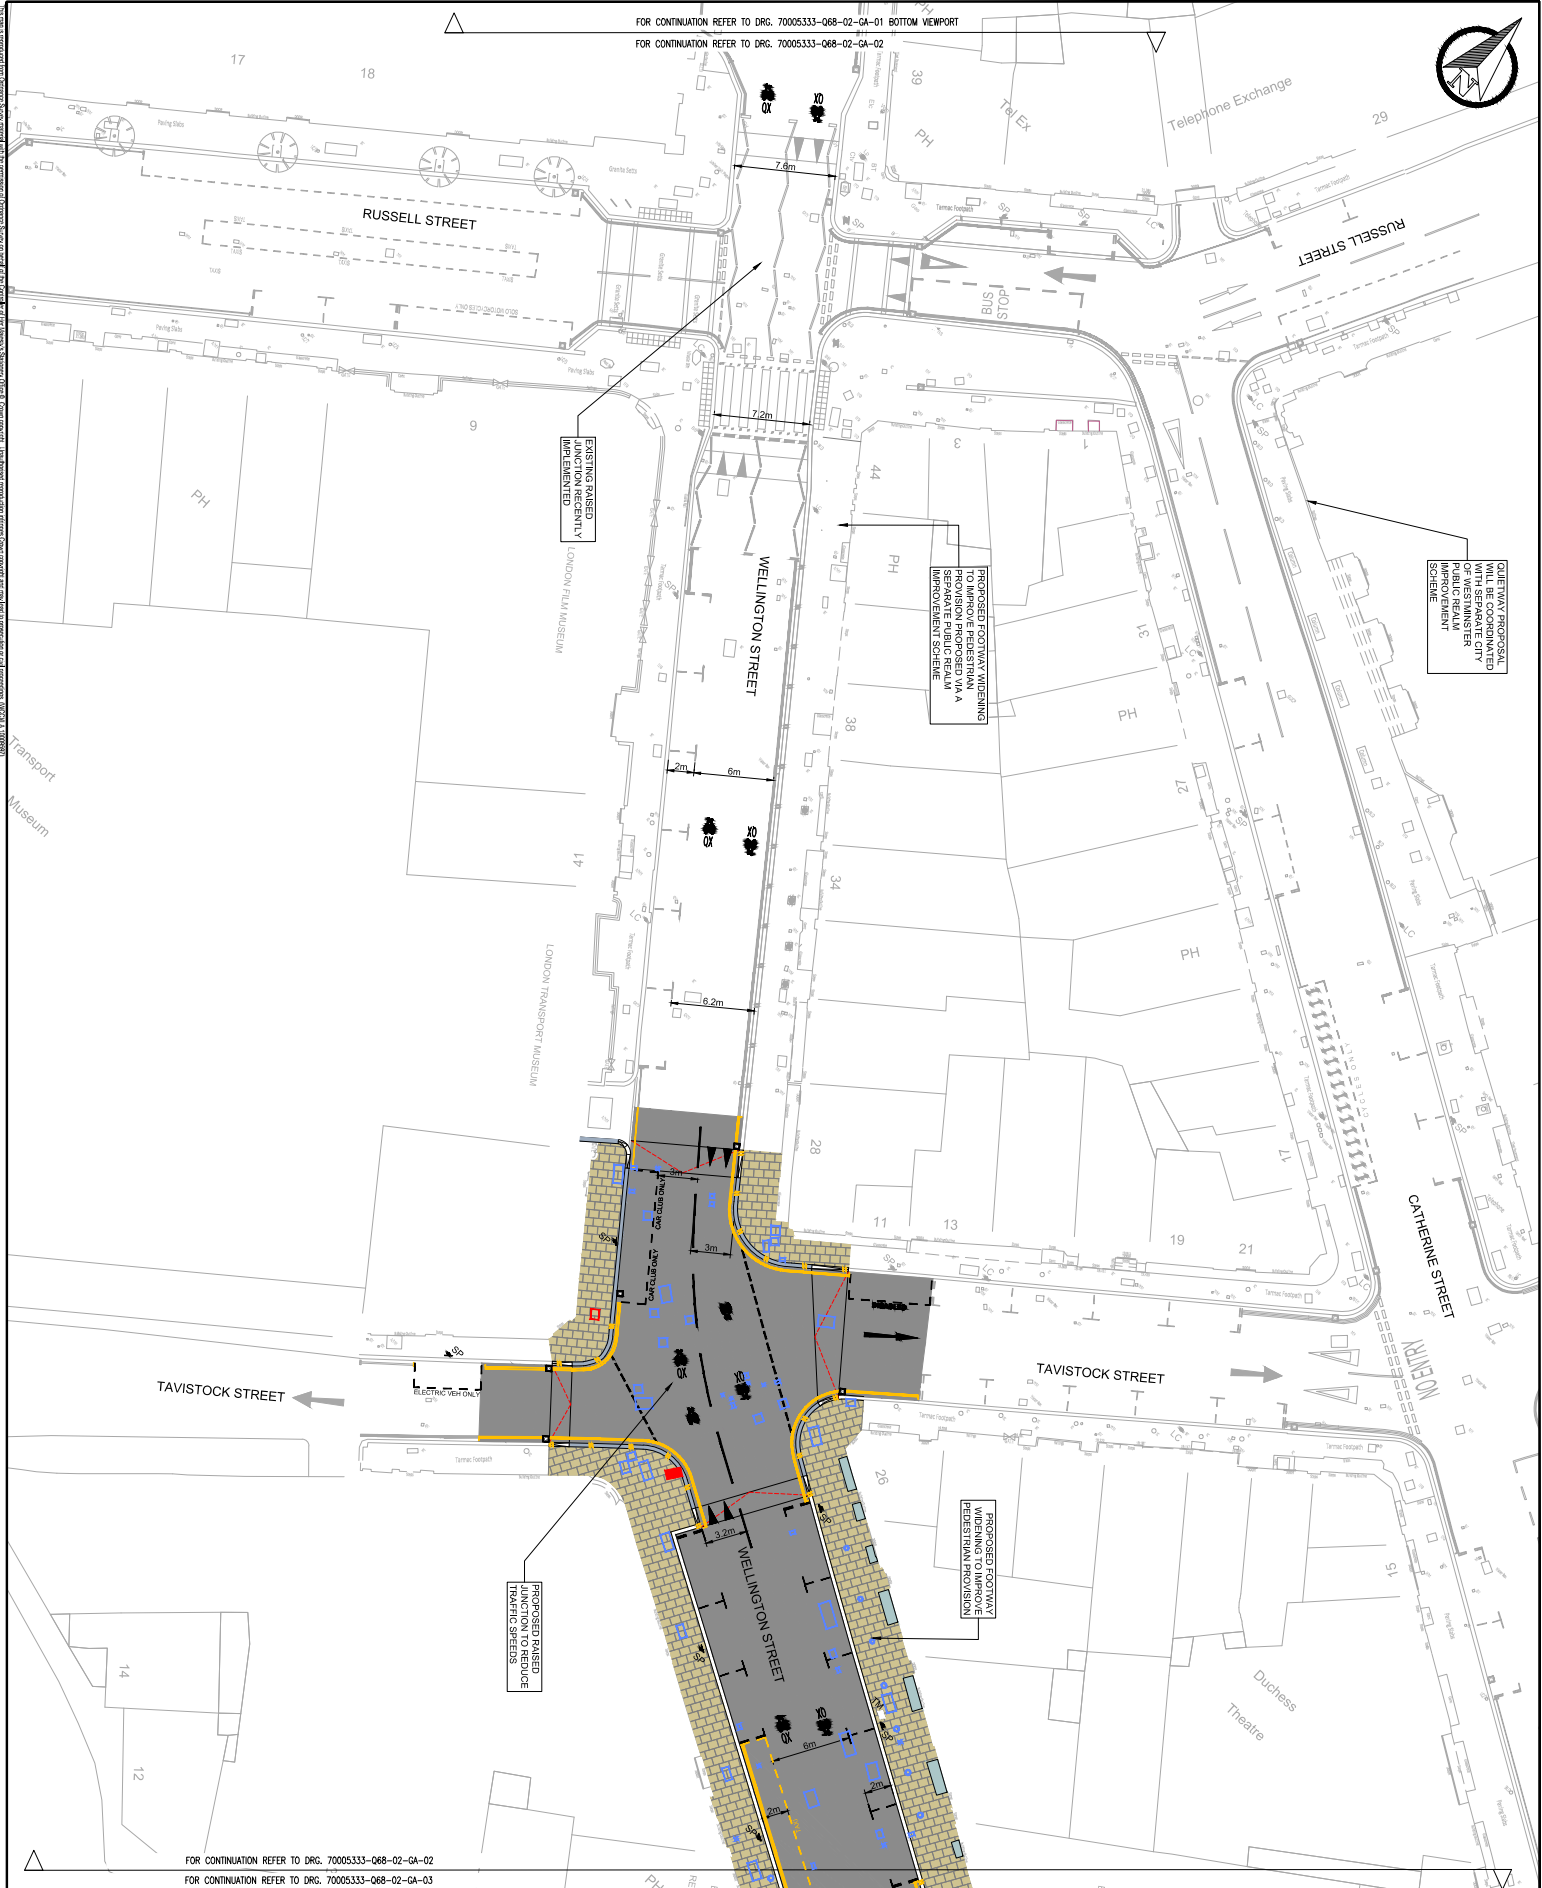

- KEY**
- EXISTING DIRECTION OF TRAVEL
  - ADJOINING CYCLE ROUTE
  - BOROUGH BOUNDARY
- REFER TO DRAWING NUMBER 70005333-068-02-GA-01 FOR ALL OTHER DETAILS RELATIVE TO THIS DRAWING
- NOTES**
1. PROPOSED LIGHTING LAYOUT HAS NOT BEEN SHOWN ON THIS SHEET DRAWING

**INITIAL DESIGN**

NO.	DATE	BY	CHKD	REVISION
1	14/02/16	CP	RF	INITIAL DESIGN

**WSP | PARSONS | BRINCKERHOFF**

25 Abchurch Lane, London EC4N 3JX  
www.parsonsbrinckerhoff.com

**CONWAY**

**City of Westminster**


**PROJECT**  
CENTRAL LONDON CYCLE GRID  
QULETWAY ROUTE BLOOMSBURY TO SOUTH BANK

**TITLE**  
ENDELL STREET TO WATERLOO BRIDGE  
GENERAL ARRANGEMENT

SHEET 2 OF 4

DATE	03/02/2016	DESIGNER	CP	CHECKED	RF
DATE	12/00	DESIGNER	CP	CHECKED	RF
DATE	03/02/2016	DESIGNER	CP	CHECKED	RF
DATE	12/00	DESIGNER	CP	CHECKED	RF

70005333-068-02-GA-02

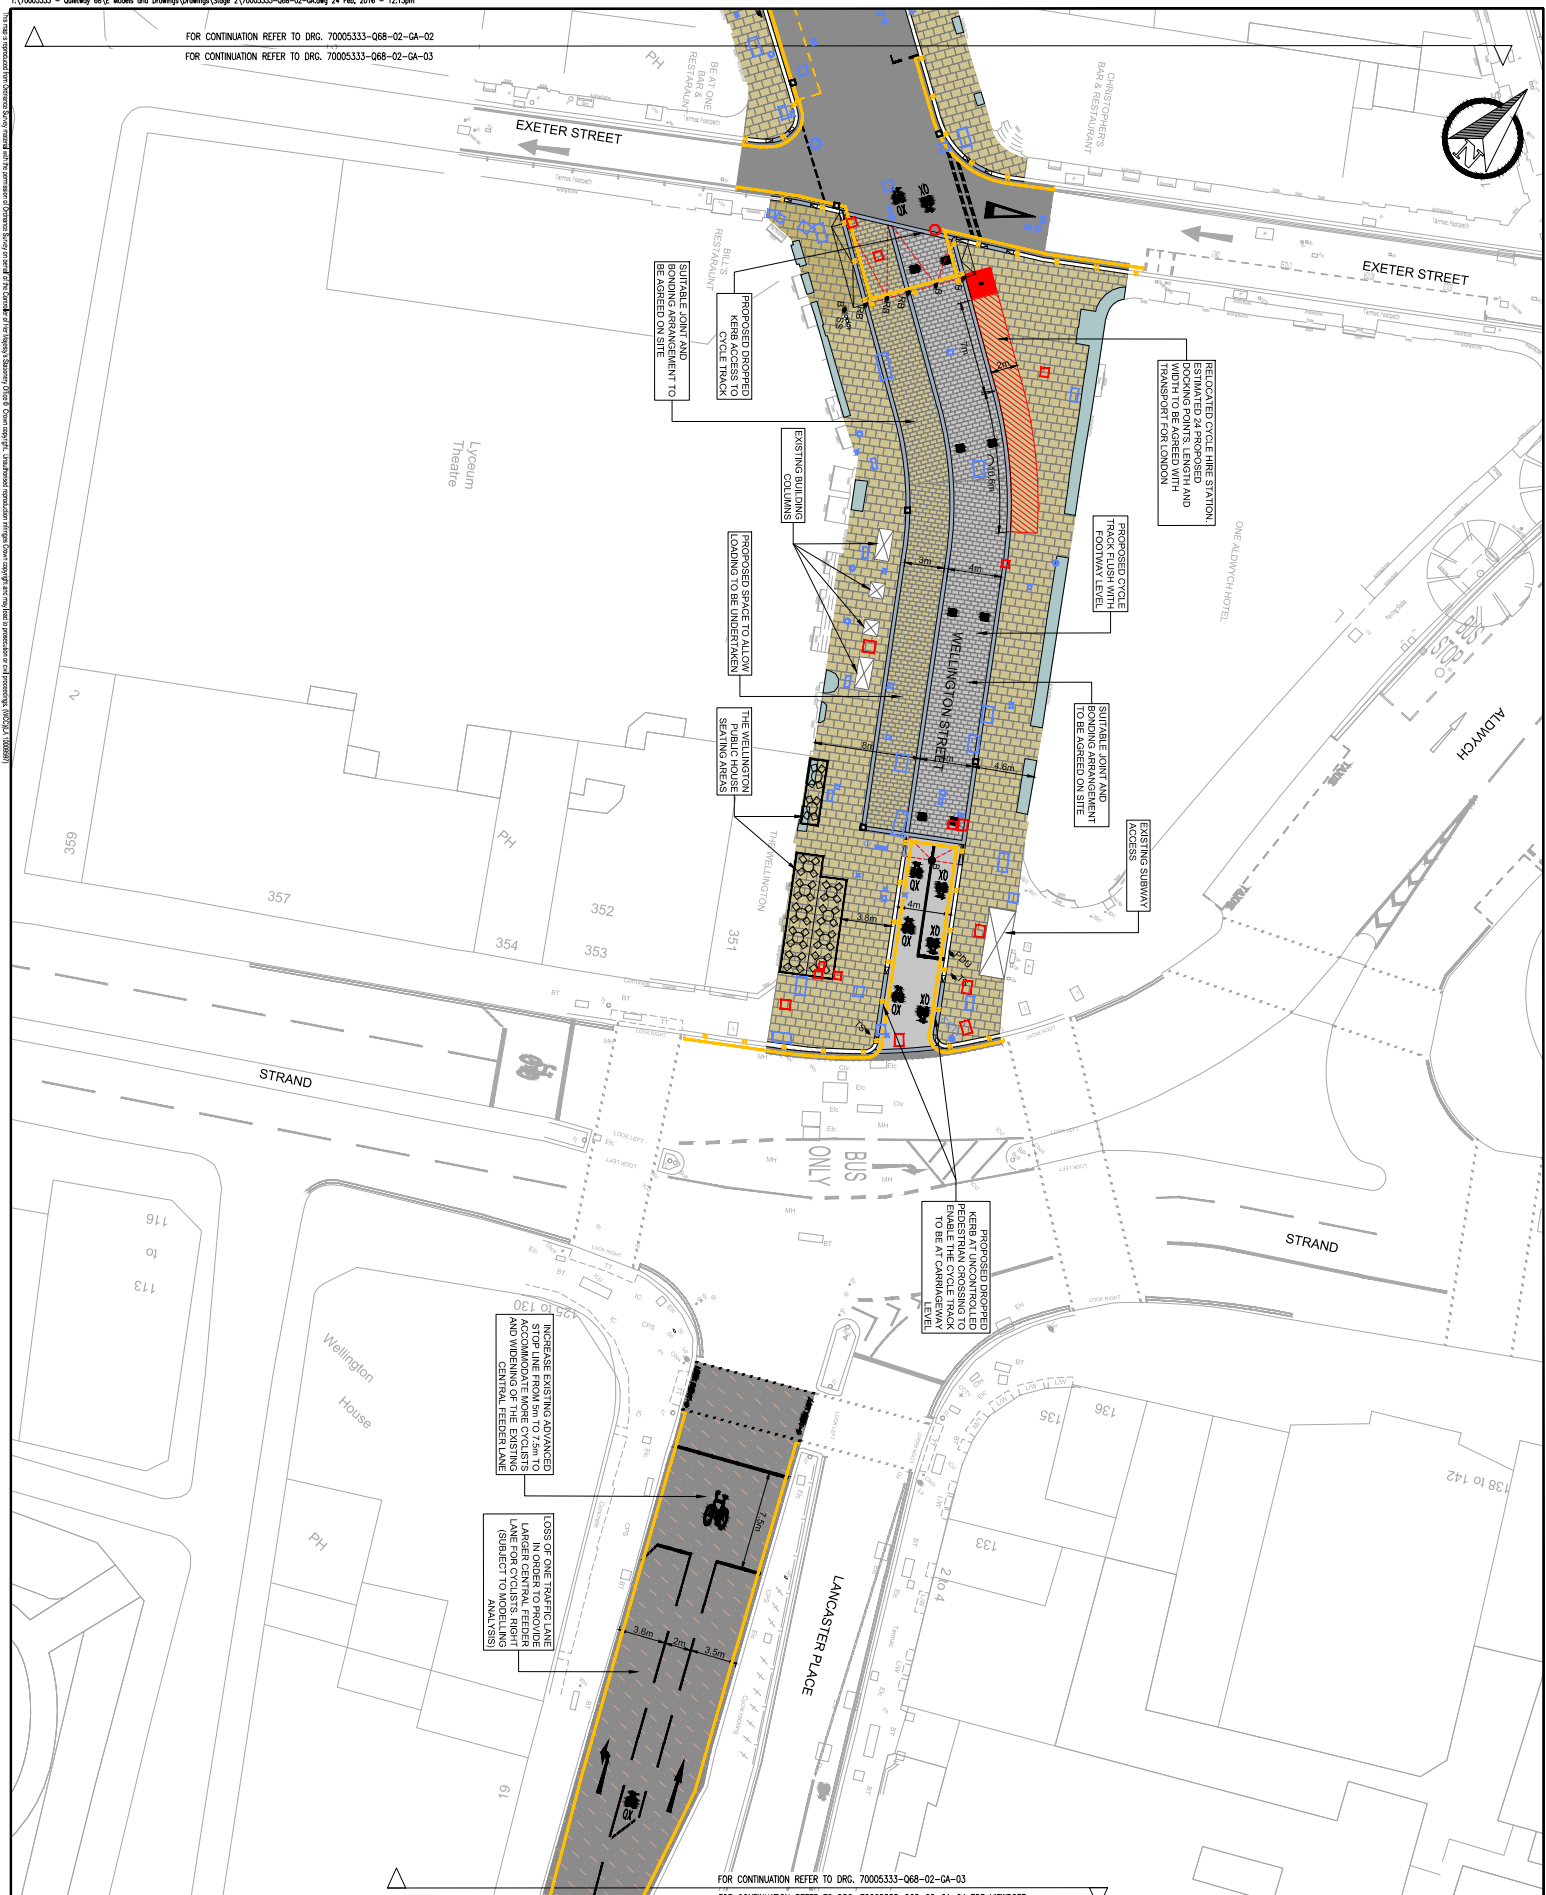

FOR CONTINUATION REFER TO DRG. 70005333-068-02-GA-03  
 FOR CONTINUATION REFER TO DRG. 70005333-068-02-GA-04 TOP VIEWPORT





- KEY**
- EXISTING DIRECTION OF TRAVEL
  - ADJOINING CYCLE ROUTE
  - PROPOSED BOUNDARY
  - BOROUGH BOUNDARY
- REFER TO DRAWING NUMBER 70005333-068-04-KEY FOR ALL OTHER DETAILS RELATIVE TO THIS DRAWING

**NOTES**

- PROPOSED LIGHTING LAYOUT HAS NOT BEEN SHOWN ON THIS SCALE DRAWING

<p>70005333-068-02-GA-03</p>		<p><b>City of Westminster</b></p>		<p><b>WSP   PARSONS   BRINCKERHOFF</b></p> <p>25 Abchurch Lane, London, EC4N 3SE, UK              www.wsp-para-brin.com</p>	
<p><b>PROJECT</b></p> <p>CENTRAL LONDON CYCLE GRID              QUIETWAY ROUTE BLOOMSBURY TO SOUTH BANK</p>		<p><b>CLIENT</b></p> <p>City of Westminster</p>		<p><b>CONTRACT</b></p> <p>INITIAL DESIGN</p>	
<p><b>TITLE</b></p> <p>ENDEL STREET TO WATERLOO BRIDGE              GENERAL ARRANGEMENT              SHEET 3 OF 4</p>		<p><b>DATE</b></p> <p>12/02/2016</p>		<p><b>SCALE</b></p> <p>AS SHOWN</p>	
<p><b>DESIGNER</b></p> <p>70005333</p>		<p><b>CHECKED</b></p> <p>70005333</p>		<p><b>DATE</b></p> <p>12/02/2016</p>	
<p><b>APPROVED</b></p> <p>70005333</p>		<p><b>DATE</b></p> <p>12/02/2016</p>		<p><b>SCALE</b></p> <p>AS SHOWN</p>	

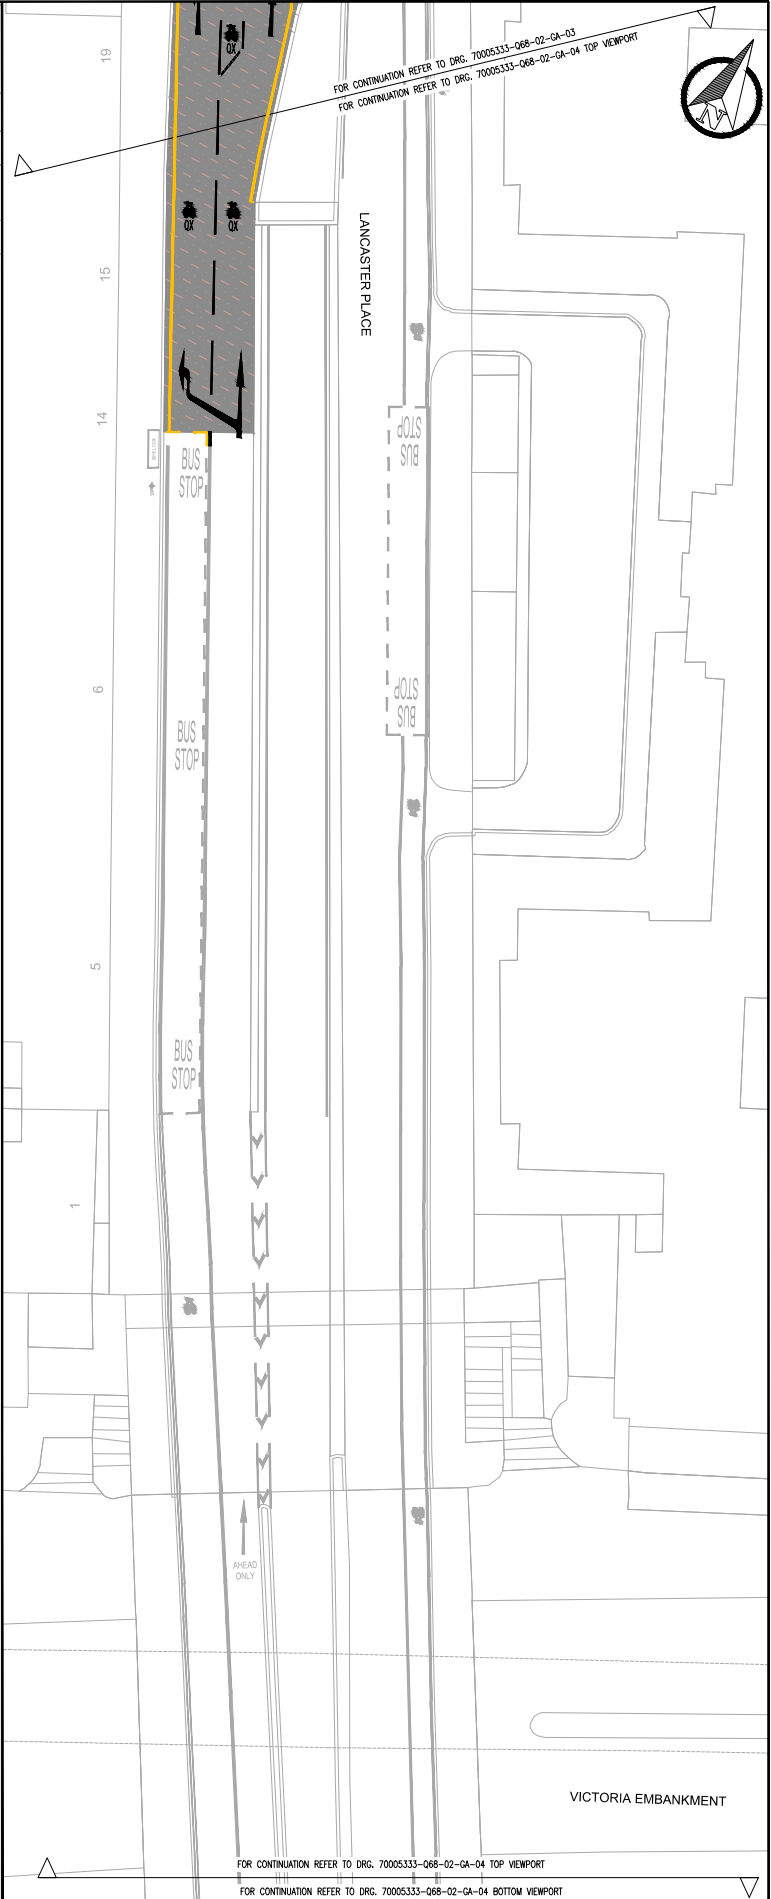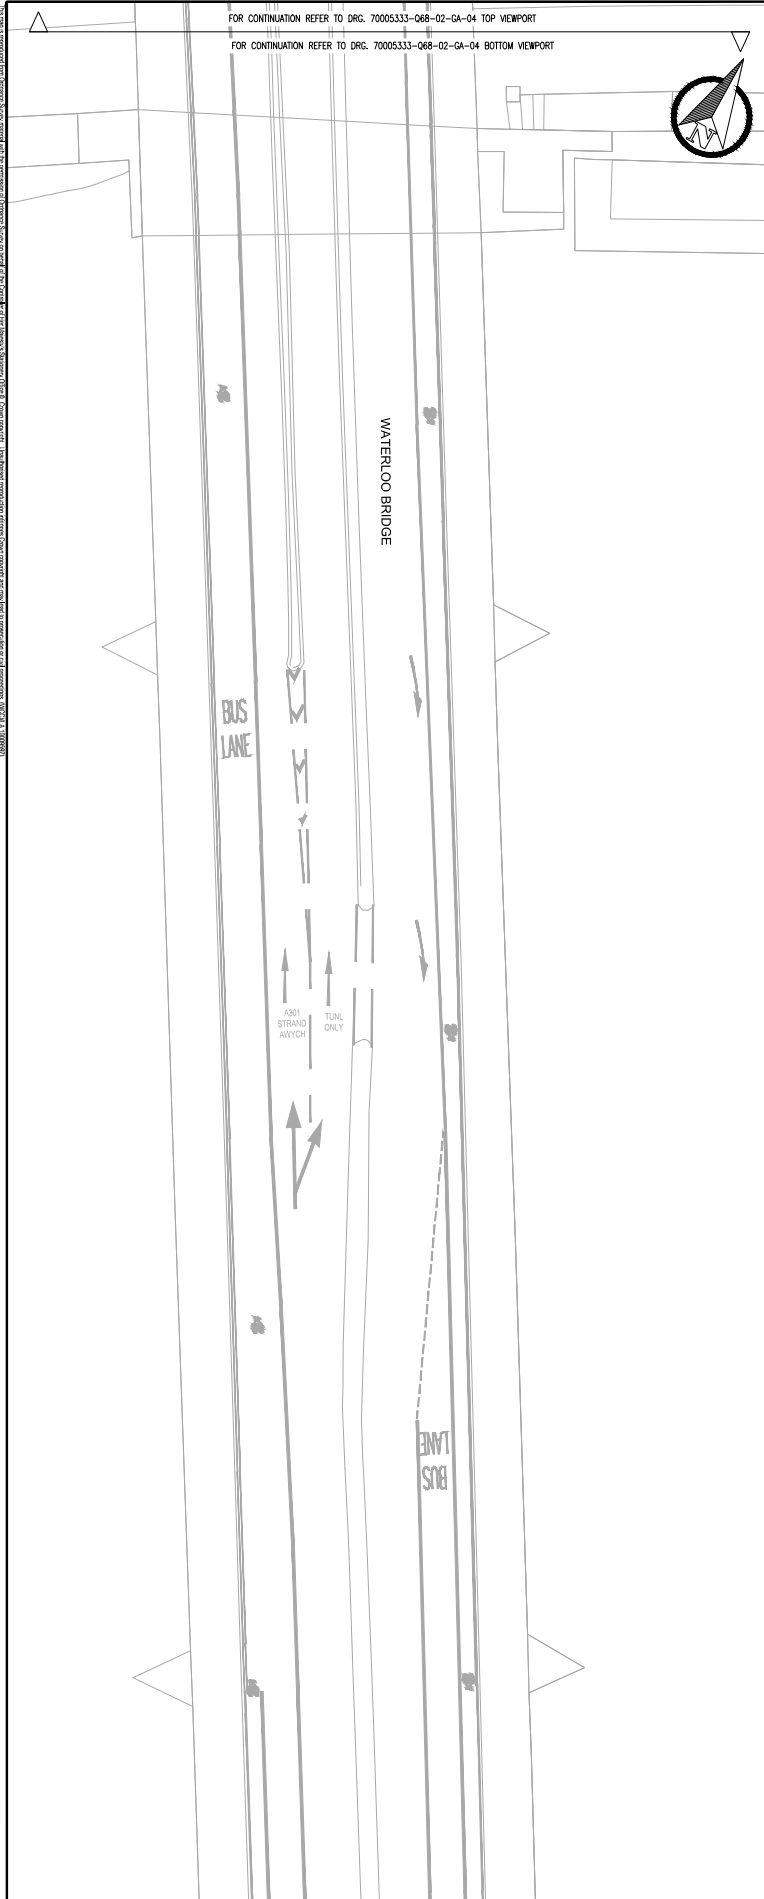

**70005333-068-02-GA-04**

SHEET 4 OF 4

NO.	DATE	BY	CHECKED	REVISION
1	03/02/2016	CEP	CH	AI

**WSP | PARSONS | BRINCKERHOFF**

20 WARREN STREET, LONDON SE1 5EQ  
www.parsonsbrinckerhoff.com

**CONWAY**

20 WARREN STREET, LONDON SE1 5EQ  
www.conway.co.uk

**City of Westminster**

CENTRAL LONDON CYCLE GRID  
QUIETWAY ROUTE BLOOMSBURY TO SOUTH BANK  
GENERAL ARRANGEMENT

**KEY**

- EXISTING DIRECTION OF TRAVEL
- ADJOINING CYCLE ROUTE
- BOUNDARY

**NOTES**

- PROPOSED LIGHTING LAYOUT HAS NOT BEEN SHOWN ON THIS SCALE DRAWINGS
- REFER TO DRAWING NUMBER 70005333-068-04 FOR FORMAL OTHER ITEMS RELATING TO THIS DRAWING

Quietway  
Bloomsbury to  
Southbank